


KEY PLAN

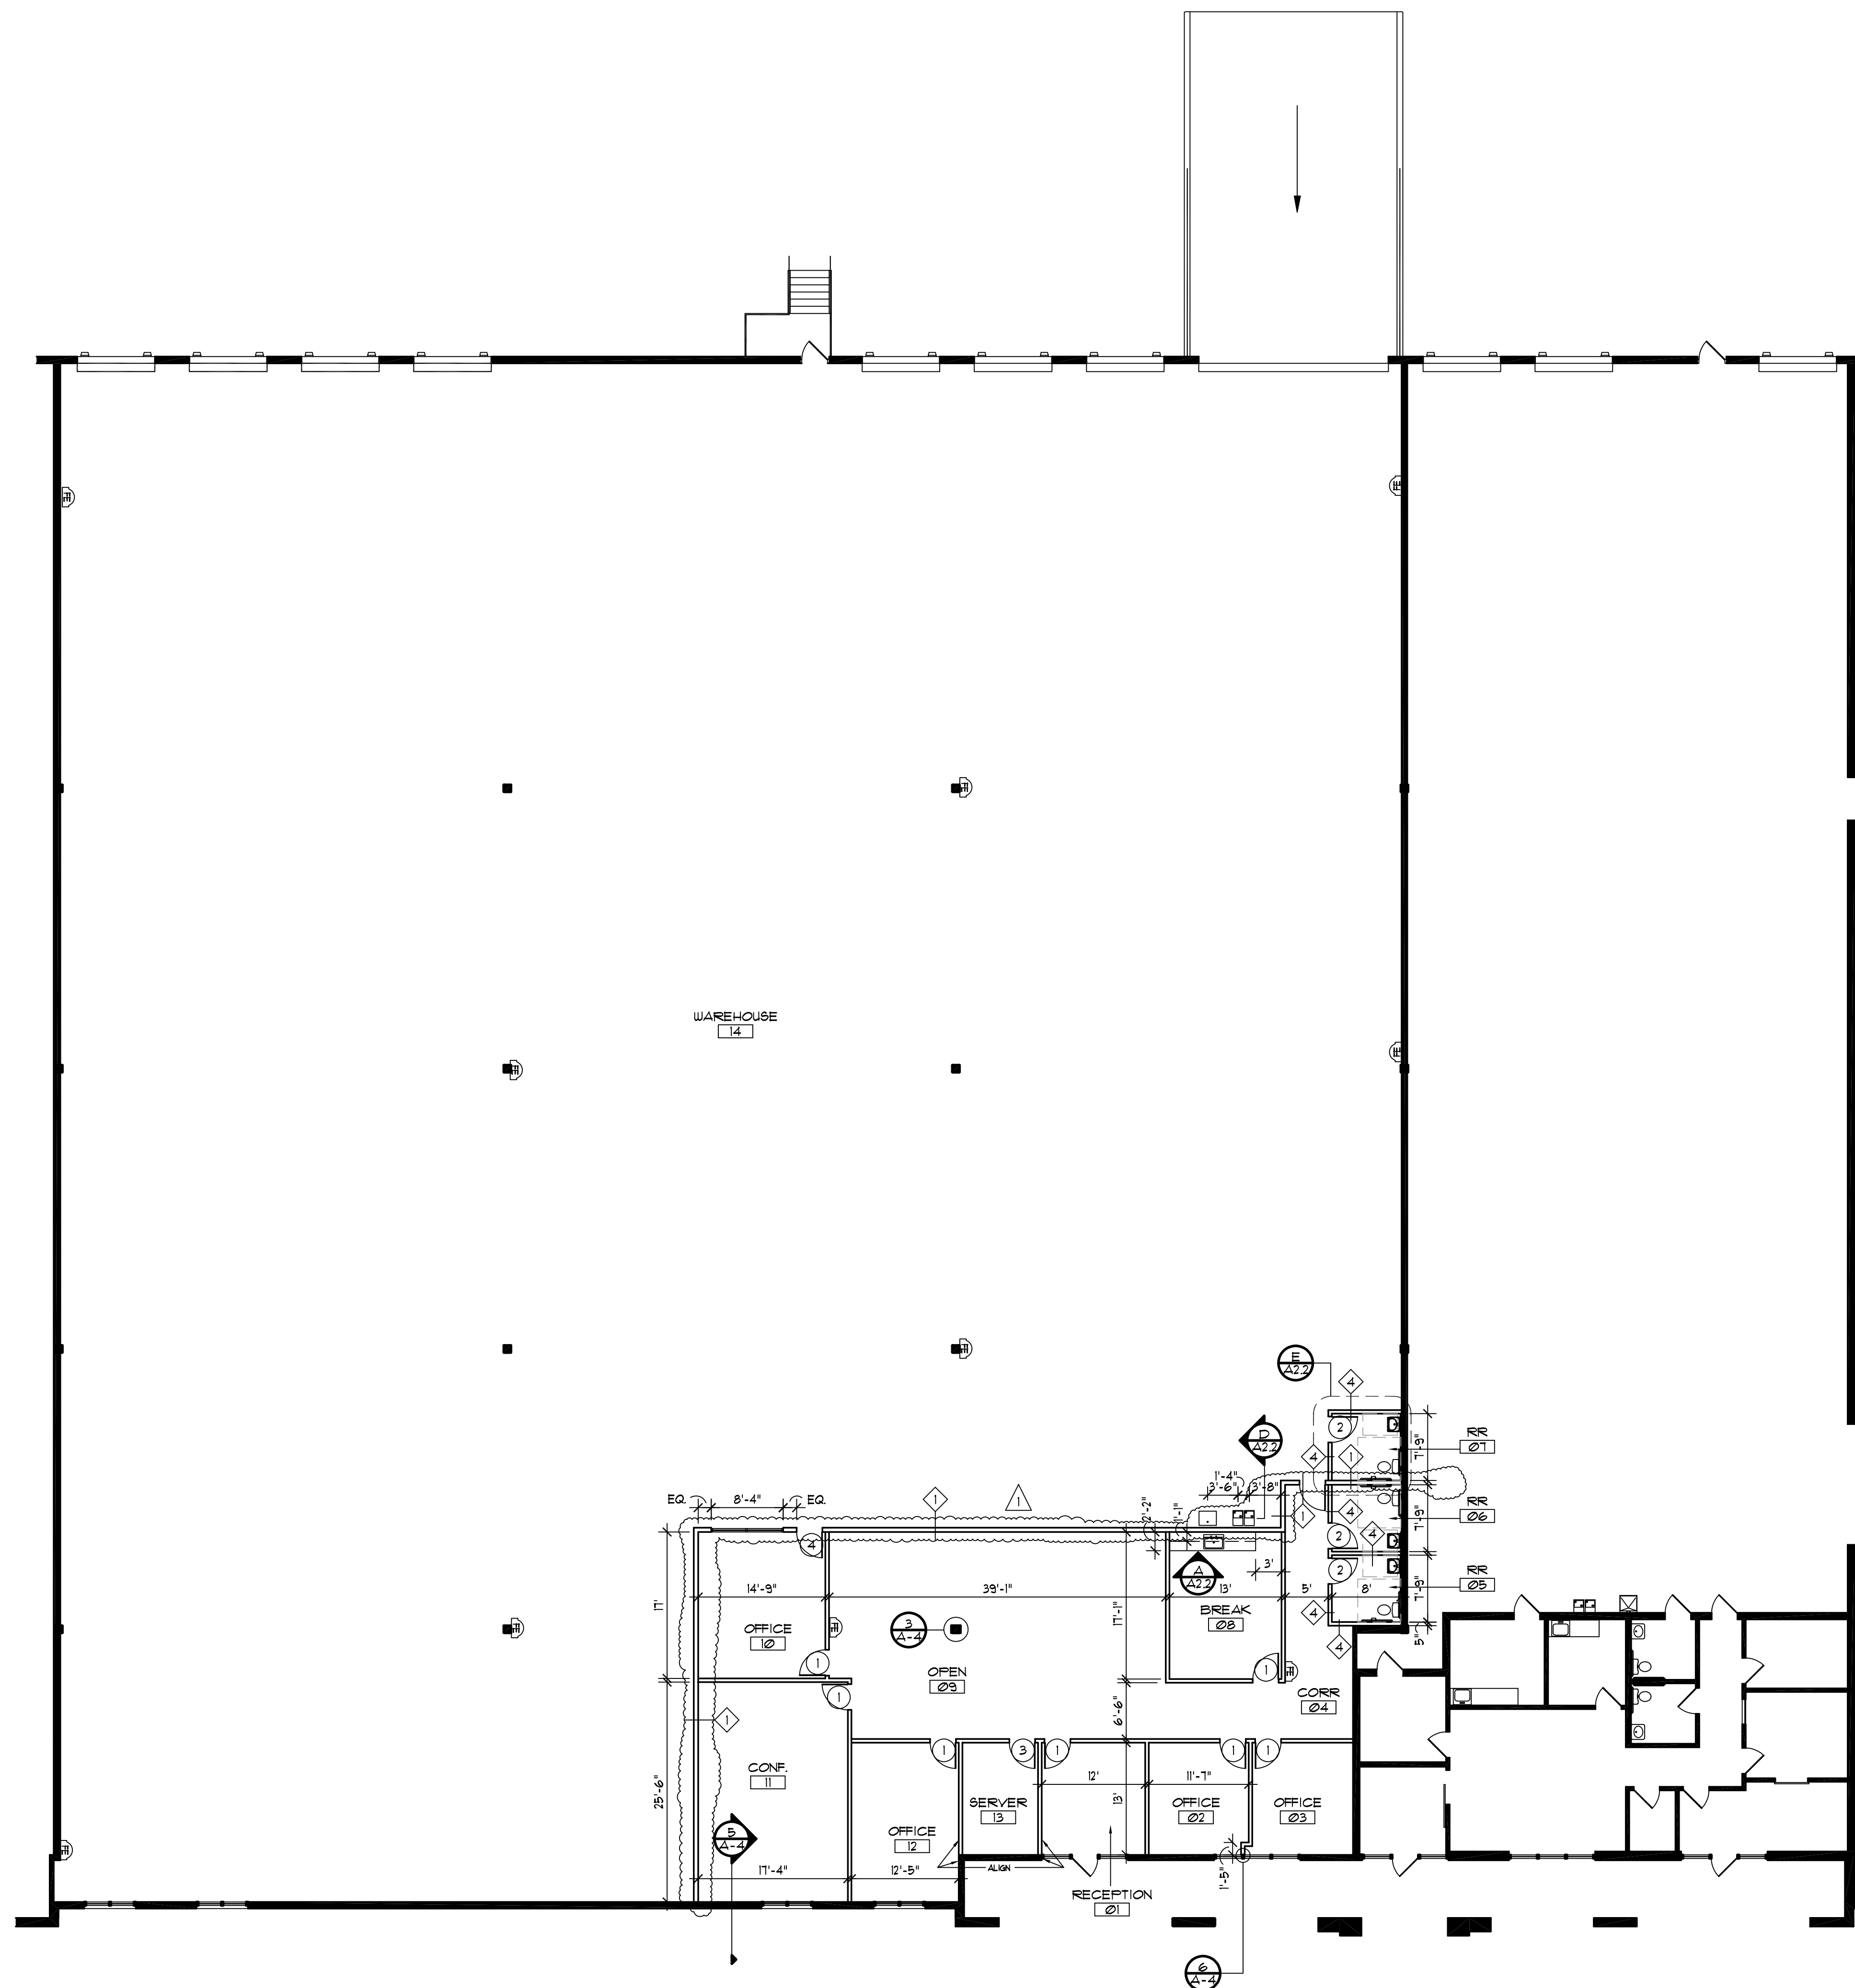

(FE) FIRE EXTINGUISHER LOCATION
 TYPE 2A10BC, TYPICAL FOR
 (8 - WAREHOUSE, 2 - OFFICE)
 FIRE EXTINGUISHERS SHALL BE
 MOUNTED AT 48" AFF TO TOP
 OF HANDLE, NOT EXCEED 75' TRAVEL
 DISTANCE & SHALL BE CURRENTLY
 TAGGED BY A LICENSED FIRE EQUIPMENT
 COMPANY. 1/3/0008 USF PER NFPA 10,
 SECTIONS 6.2.1.1 AND 6.2.1.2

TEWES
 DESIGN
 GROUP, LLC

200 SOUTH BISCATINE BLVD.
 SUITE 1140
 MIAMI, FLORIDA 33131
 305-372-3335

STEPHEN H. TEWES
 ARCHITECT OF RECORD
 AA26007916
 FLORIDA REGISTRATION

DATE:

MEDLEY LOGISTICS
 SPEC SPACE
 12604 NW 115TH AVE, MEDLEY FL
 FLOOR PLAN

PROJECT NO.: 15-036002
 DRAWING NO.: 002FFA
 SCALE: 3/32" = 1'-0"
 DATE: 06-28-16
 DRAWN BY: KAL

ISSUED:
 12-13-16 REVISED

SHEET NO.:
 A-2